


G:\2014 Proj\14365006\Drawg\Site Plan 11-20-14.dwg

PLOT DATE: Feb 16, 2015 - 10:53am

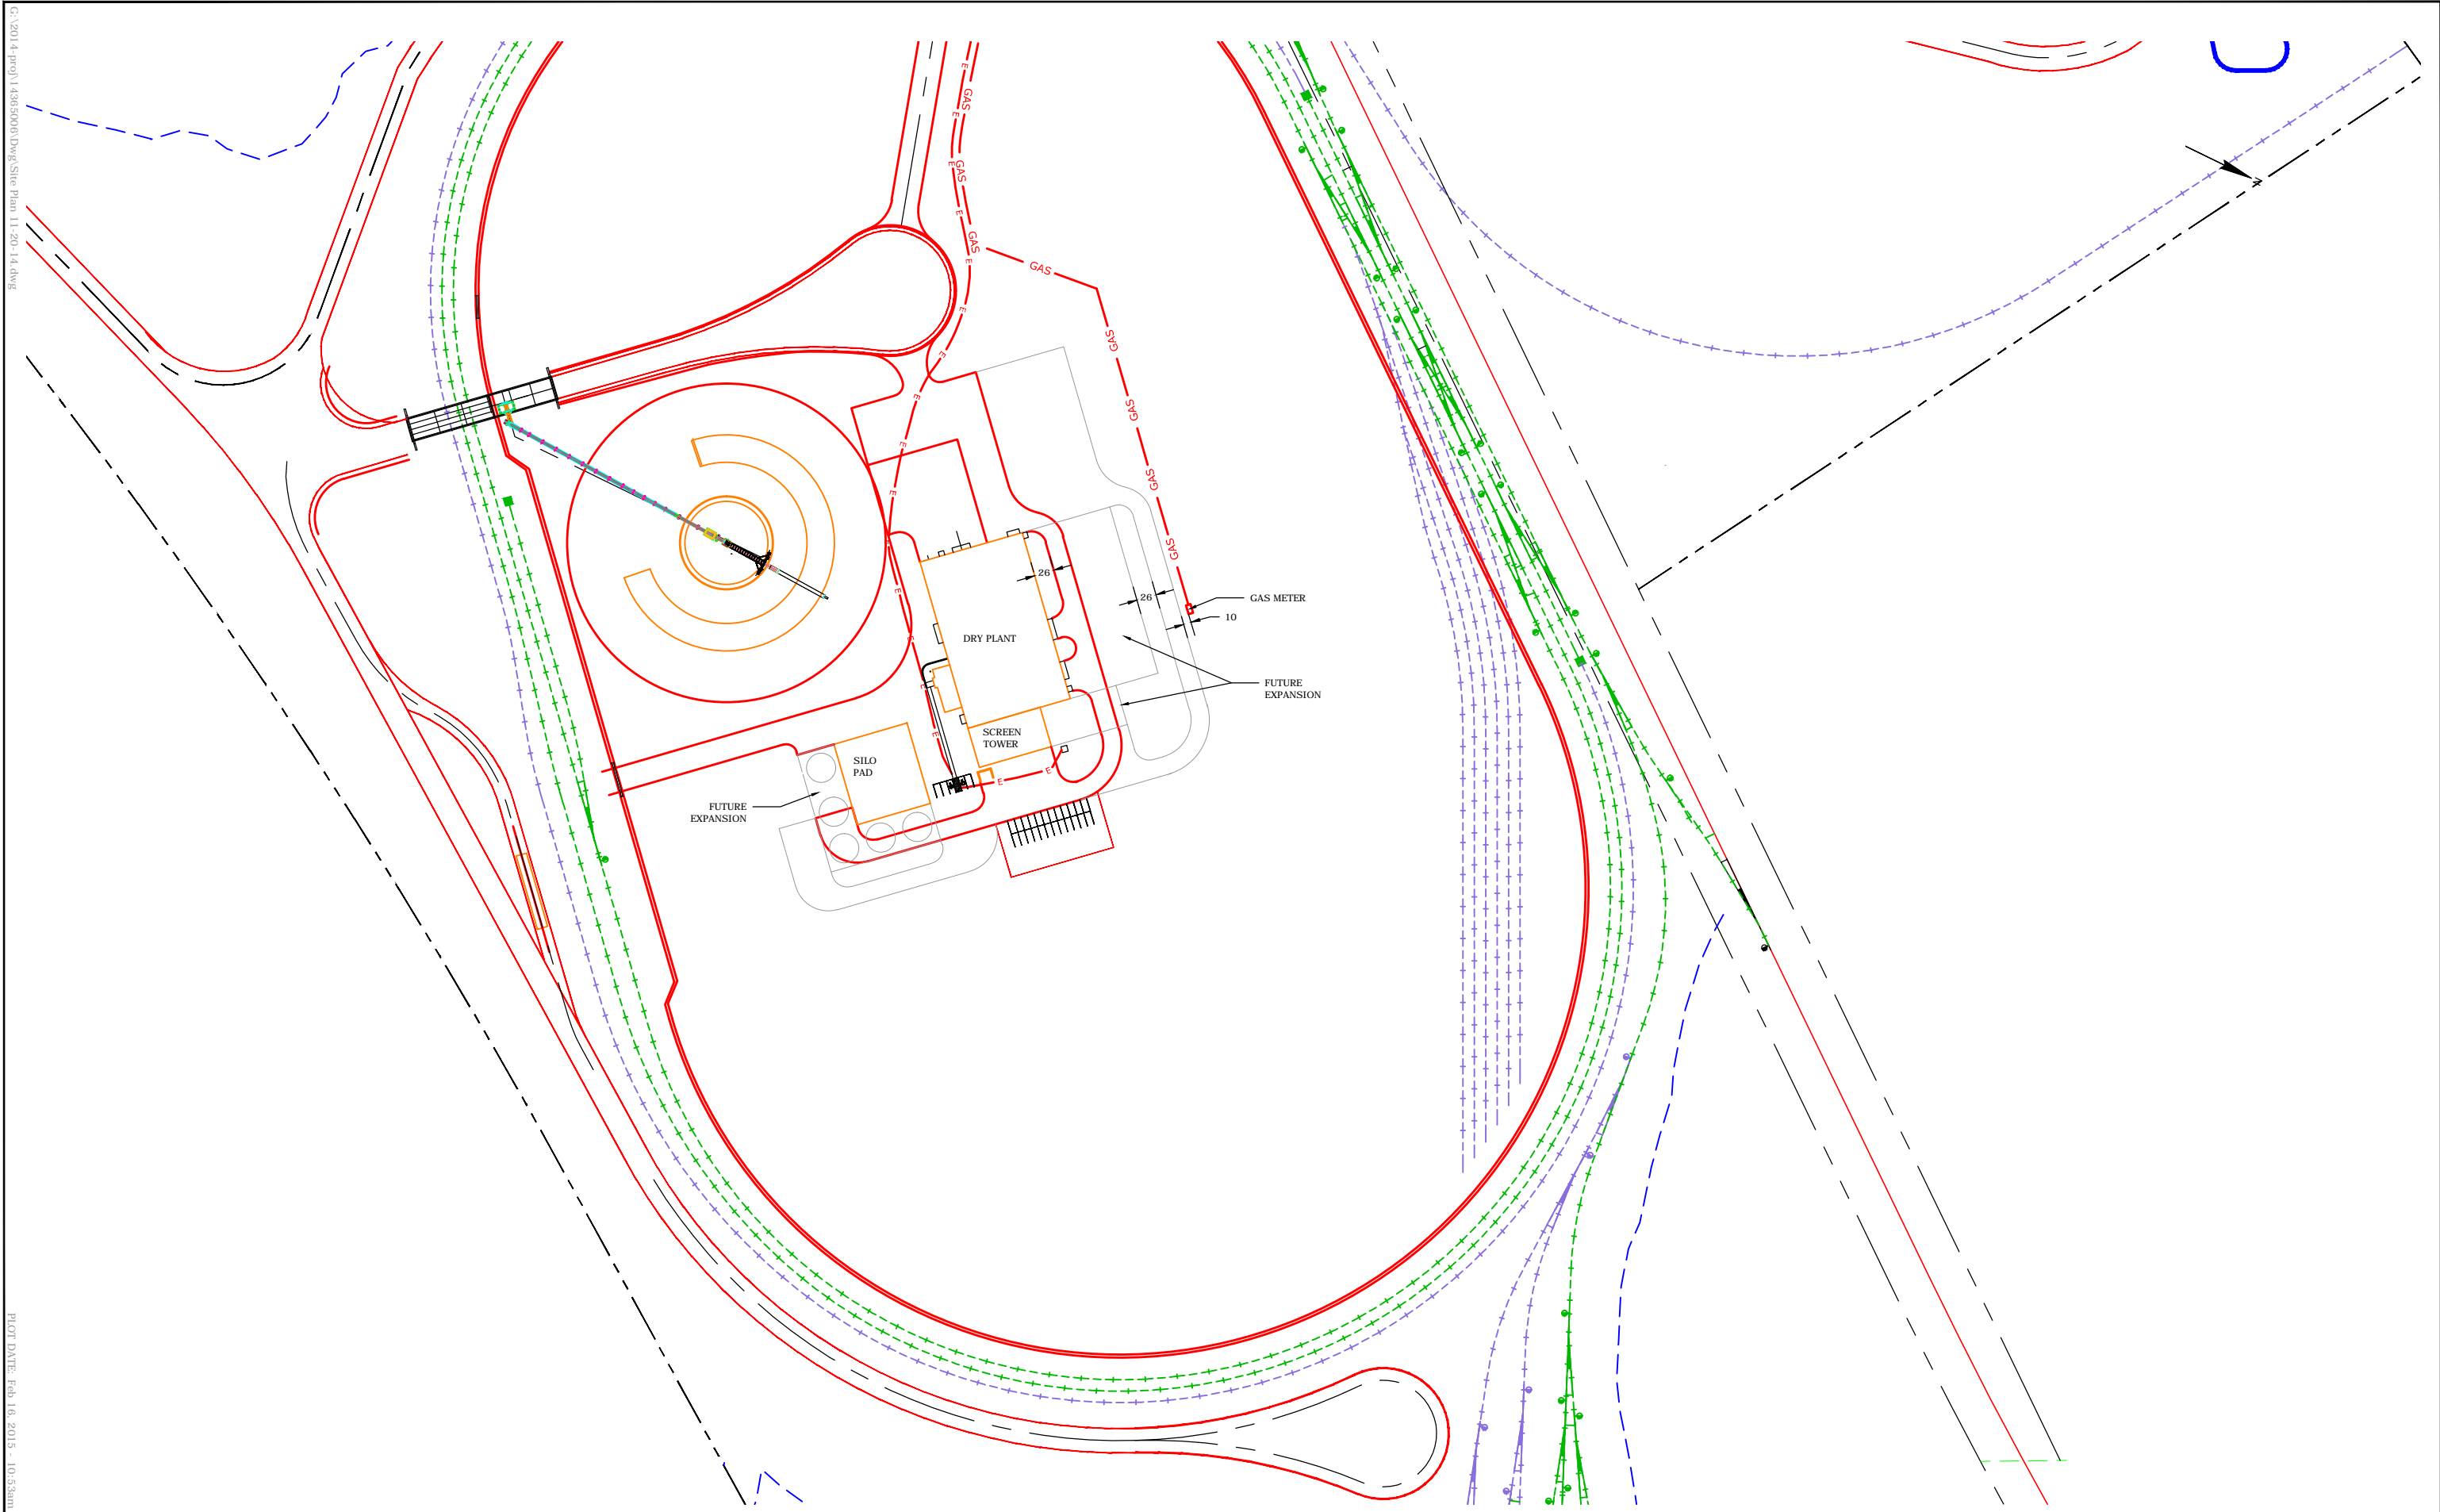

NO.	BY	DATE	REVISIONS

PROJECT MANAGER **BRUCE MARKGREN**
 CHECKED BY:
 APPROVED BY:

COOPER ENGINEERING
 2600 COLLEGE DRIVE, P.O. BOX 230
 RICE LAKE, WISCONSIN 54868-0230
 TELEPHONE (715) 234-7008
 FAX (715) 234-1025

NORTHERN INDUSTRIAL SANDS

SHEET DESCRIPTION
**DRY PLANT
 SITE LAYOUT**

DATE	1-12-15
SCALE	0 25 50

DRAWN BY	-
PROJECT NO.	14365011
SHEET NO.	1